

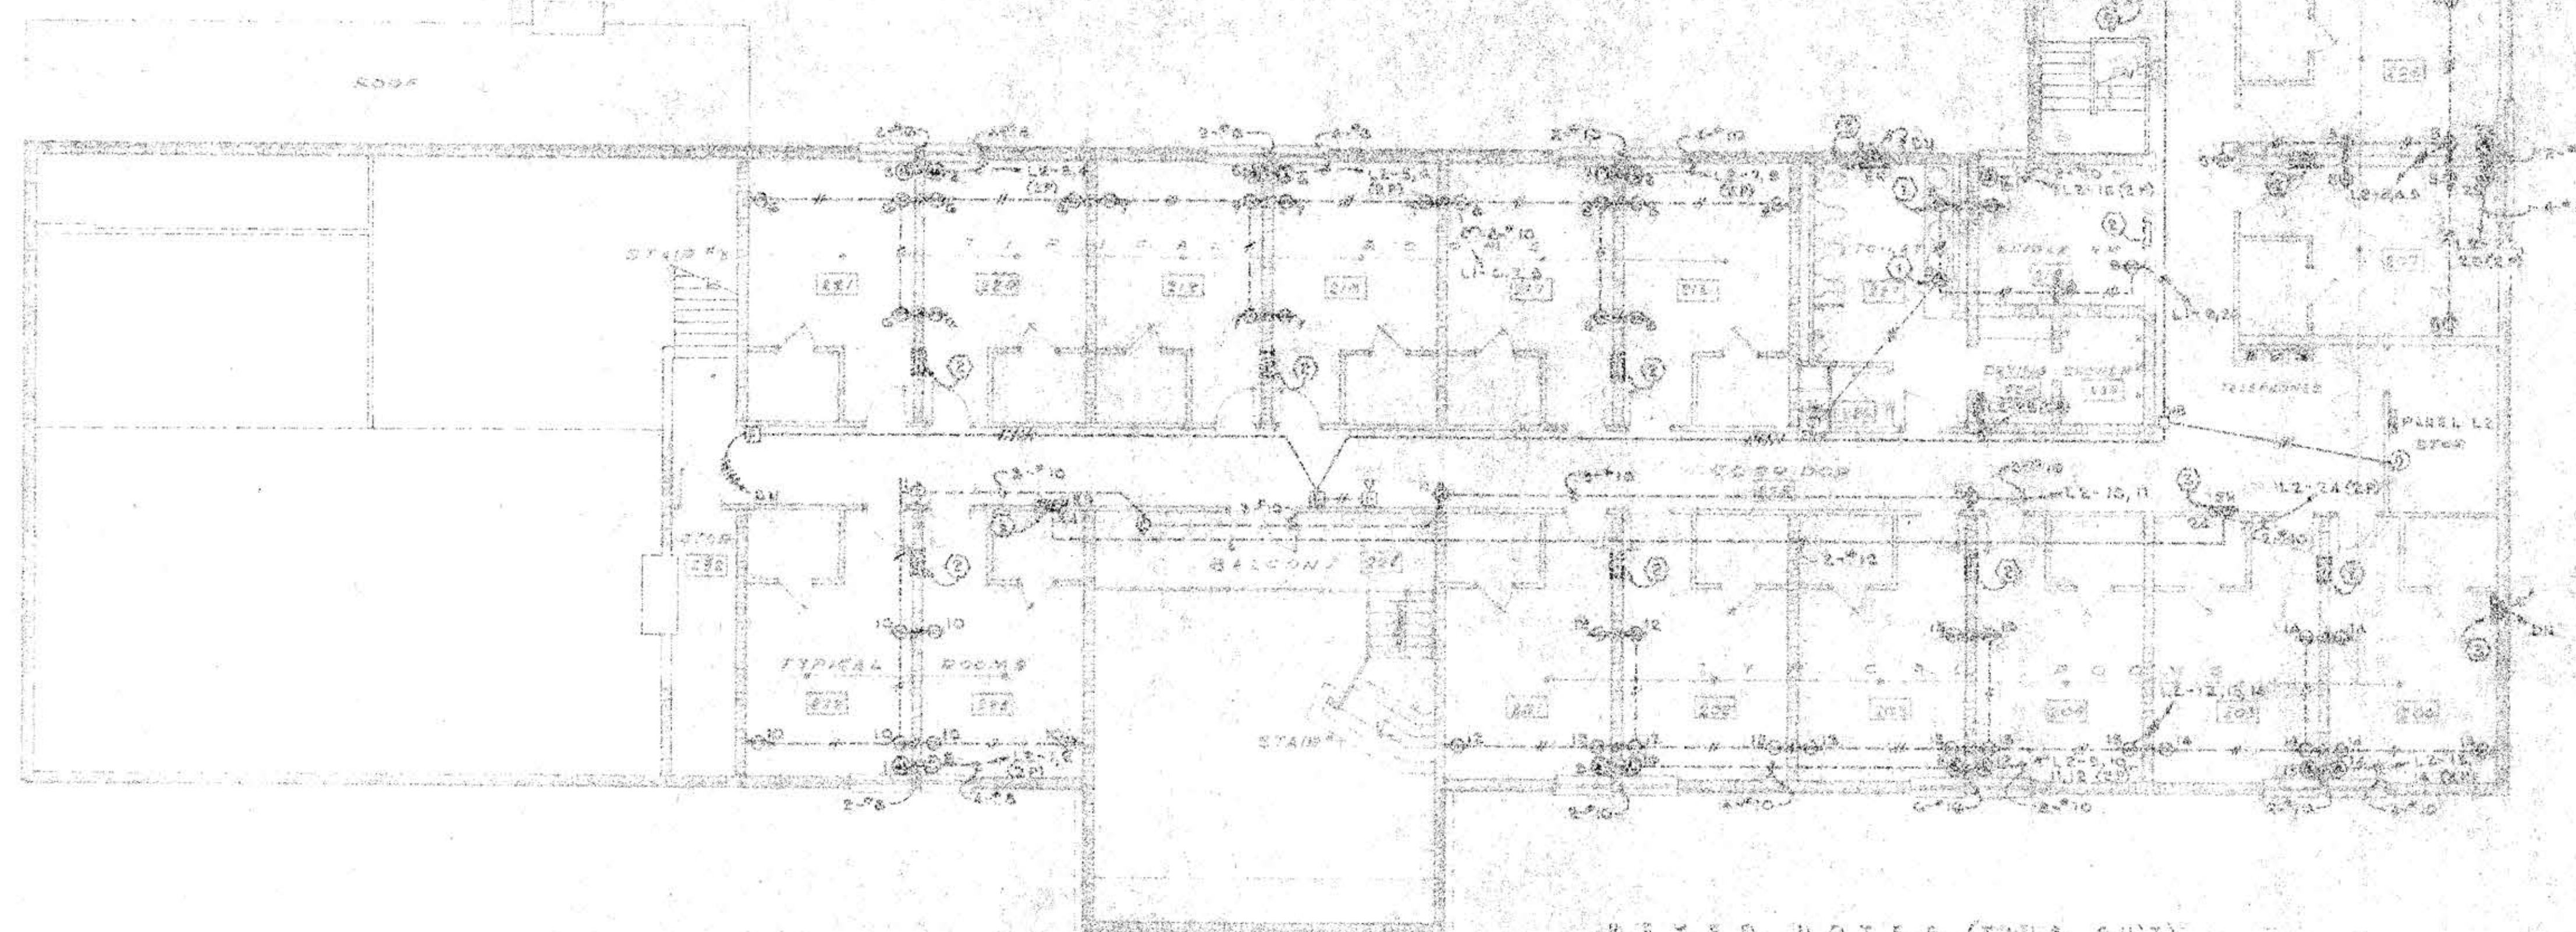
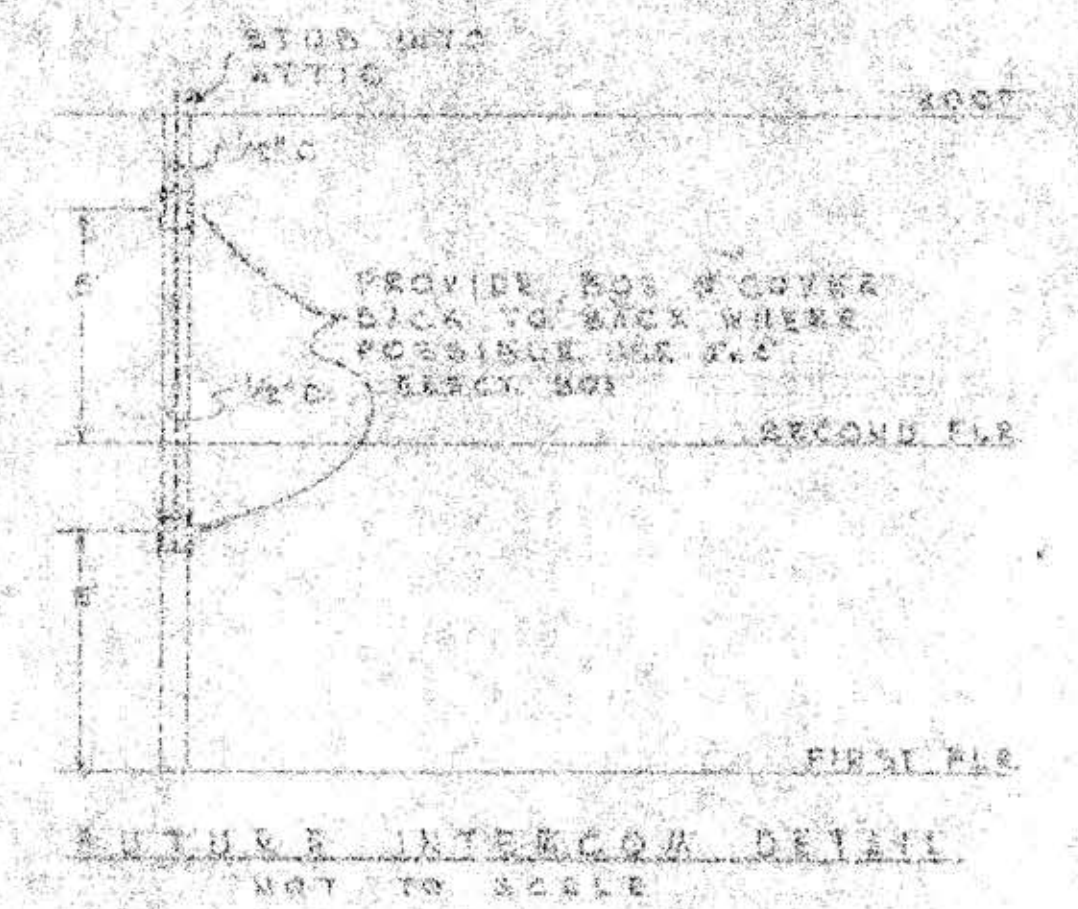


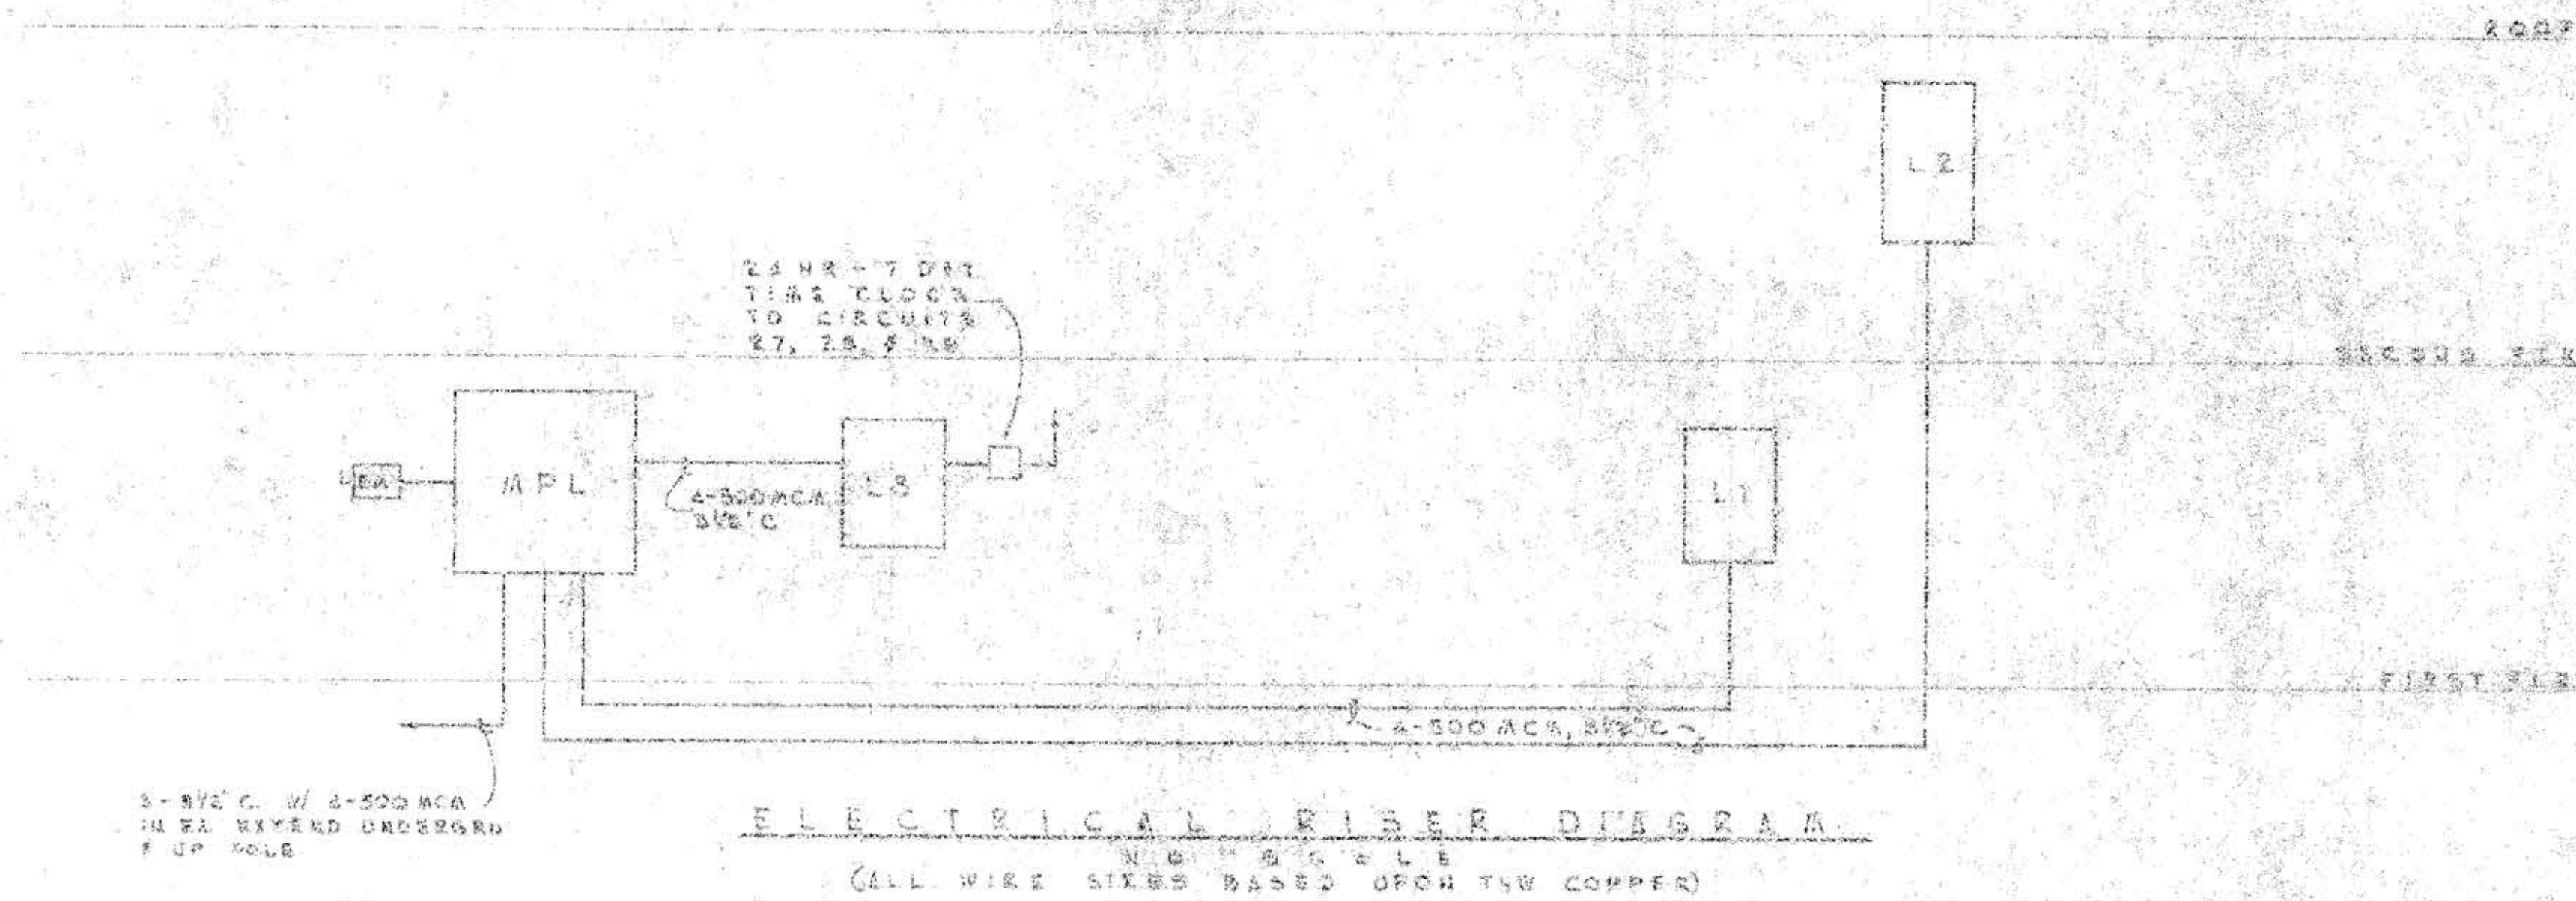



- KEYED NOTES (THIS SH'T)
- ① MOUNT RECEPTACLES ABOVE COUNTER
 - ② ROUGH-IN FOR FUTURE INTERCOM. SEE DETAIL THIS SH'T
 - ③ ELECTRIC HEATER - 557.5 CONNECT BY ELECT. CONTR. FURNISHED BY HYG. CONTR.

SECOND FLOOR PLAN

BETA CHI/KAPPA SIGMA HOUSE	
1016 AND 1018 UNIVERSITY FRATERNITY SUBDIVISION	
UNIVERSITY OF MISSOURI	
COLUMBIA, MISSOURI	
DRAWN BY: J. B. S. & L. E.	
CHECKED BY: J. B. S. & L. E.	
DATE: 10/1/50	
PROJECT: BETA CHI/KAPPA SIGMA HOUSE	
SHEET: 1 OF 1	

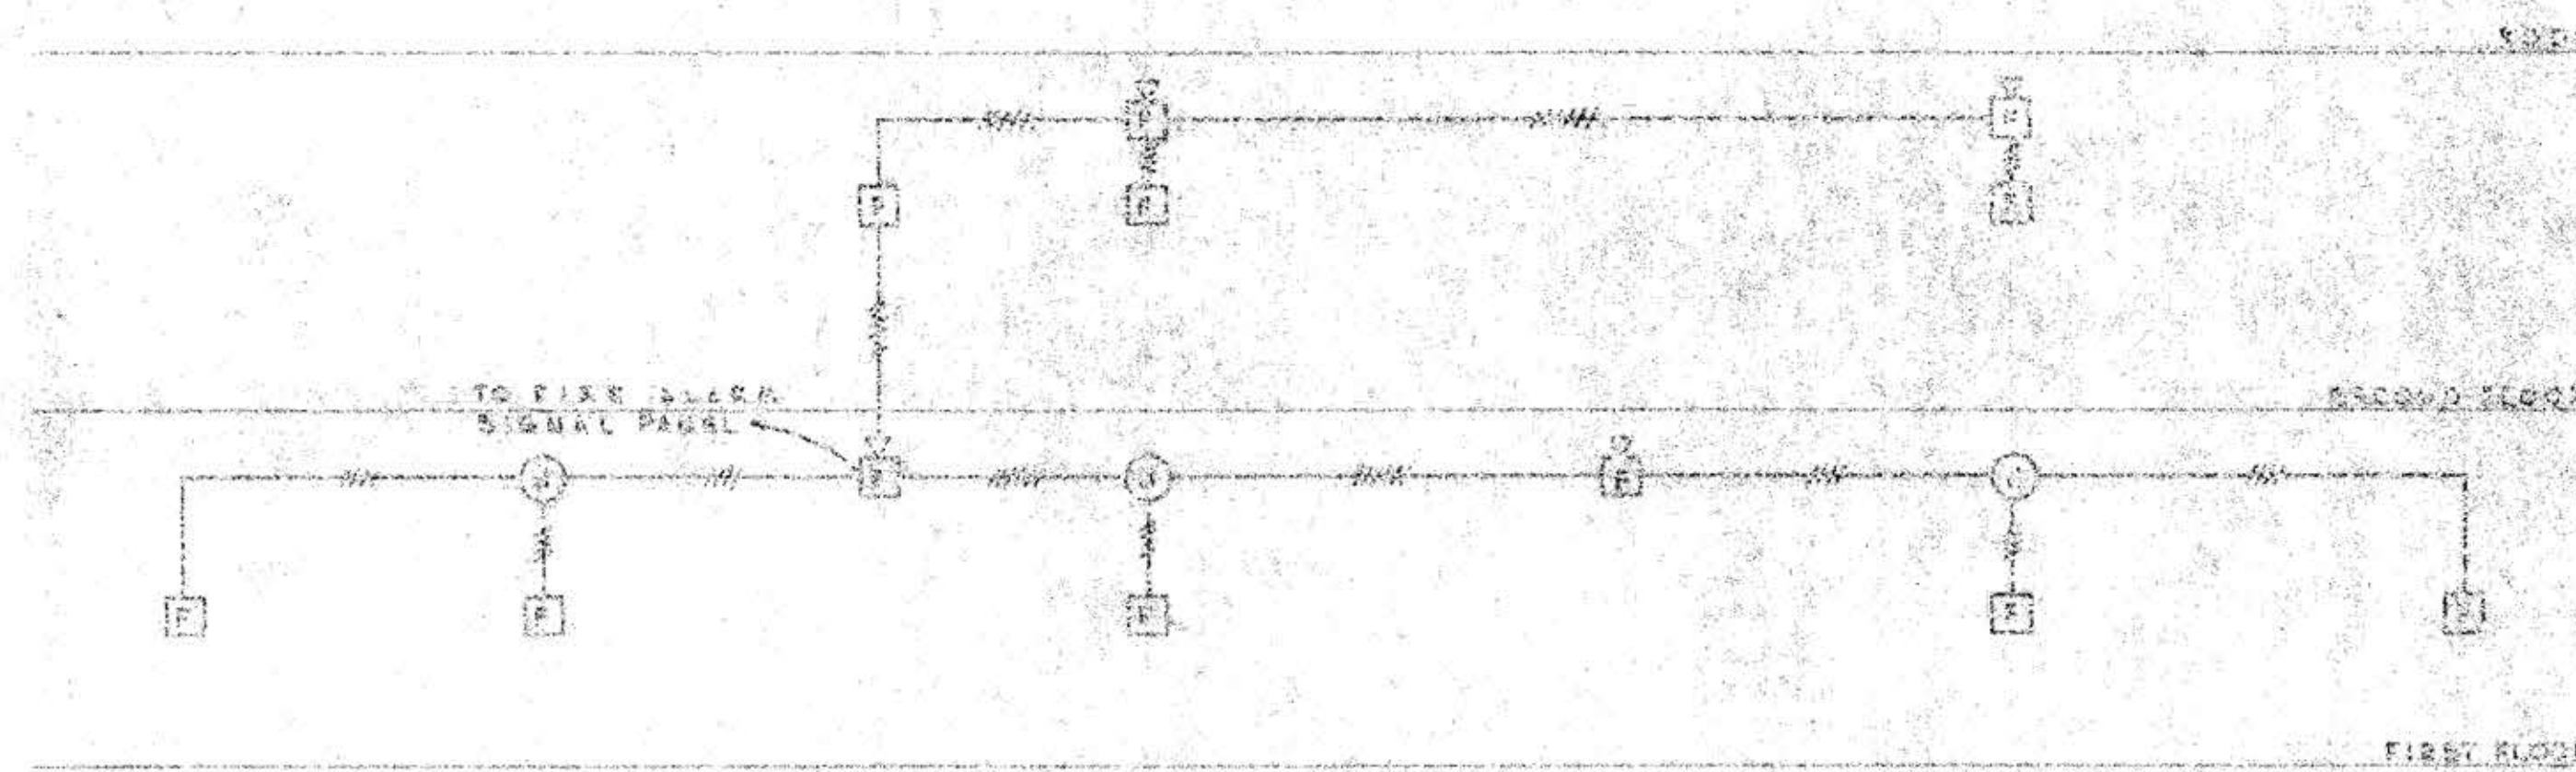

FIRE ALARM RISER DIAGRAM
NO. 24412

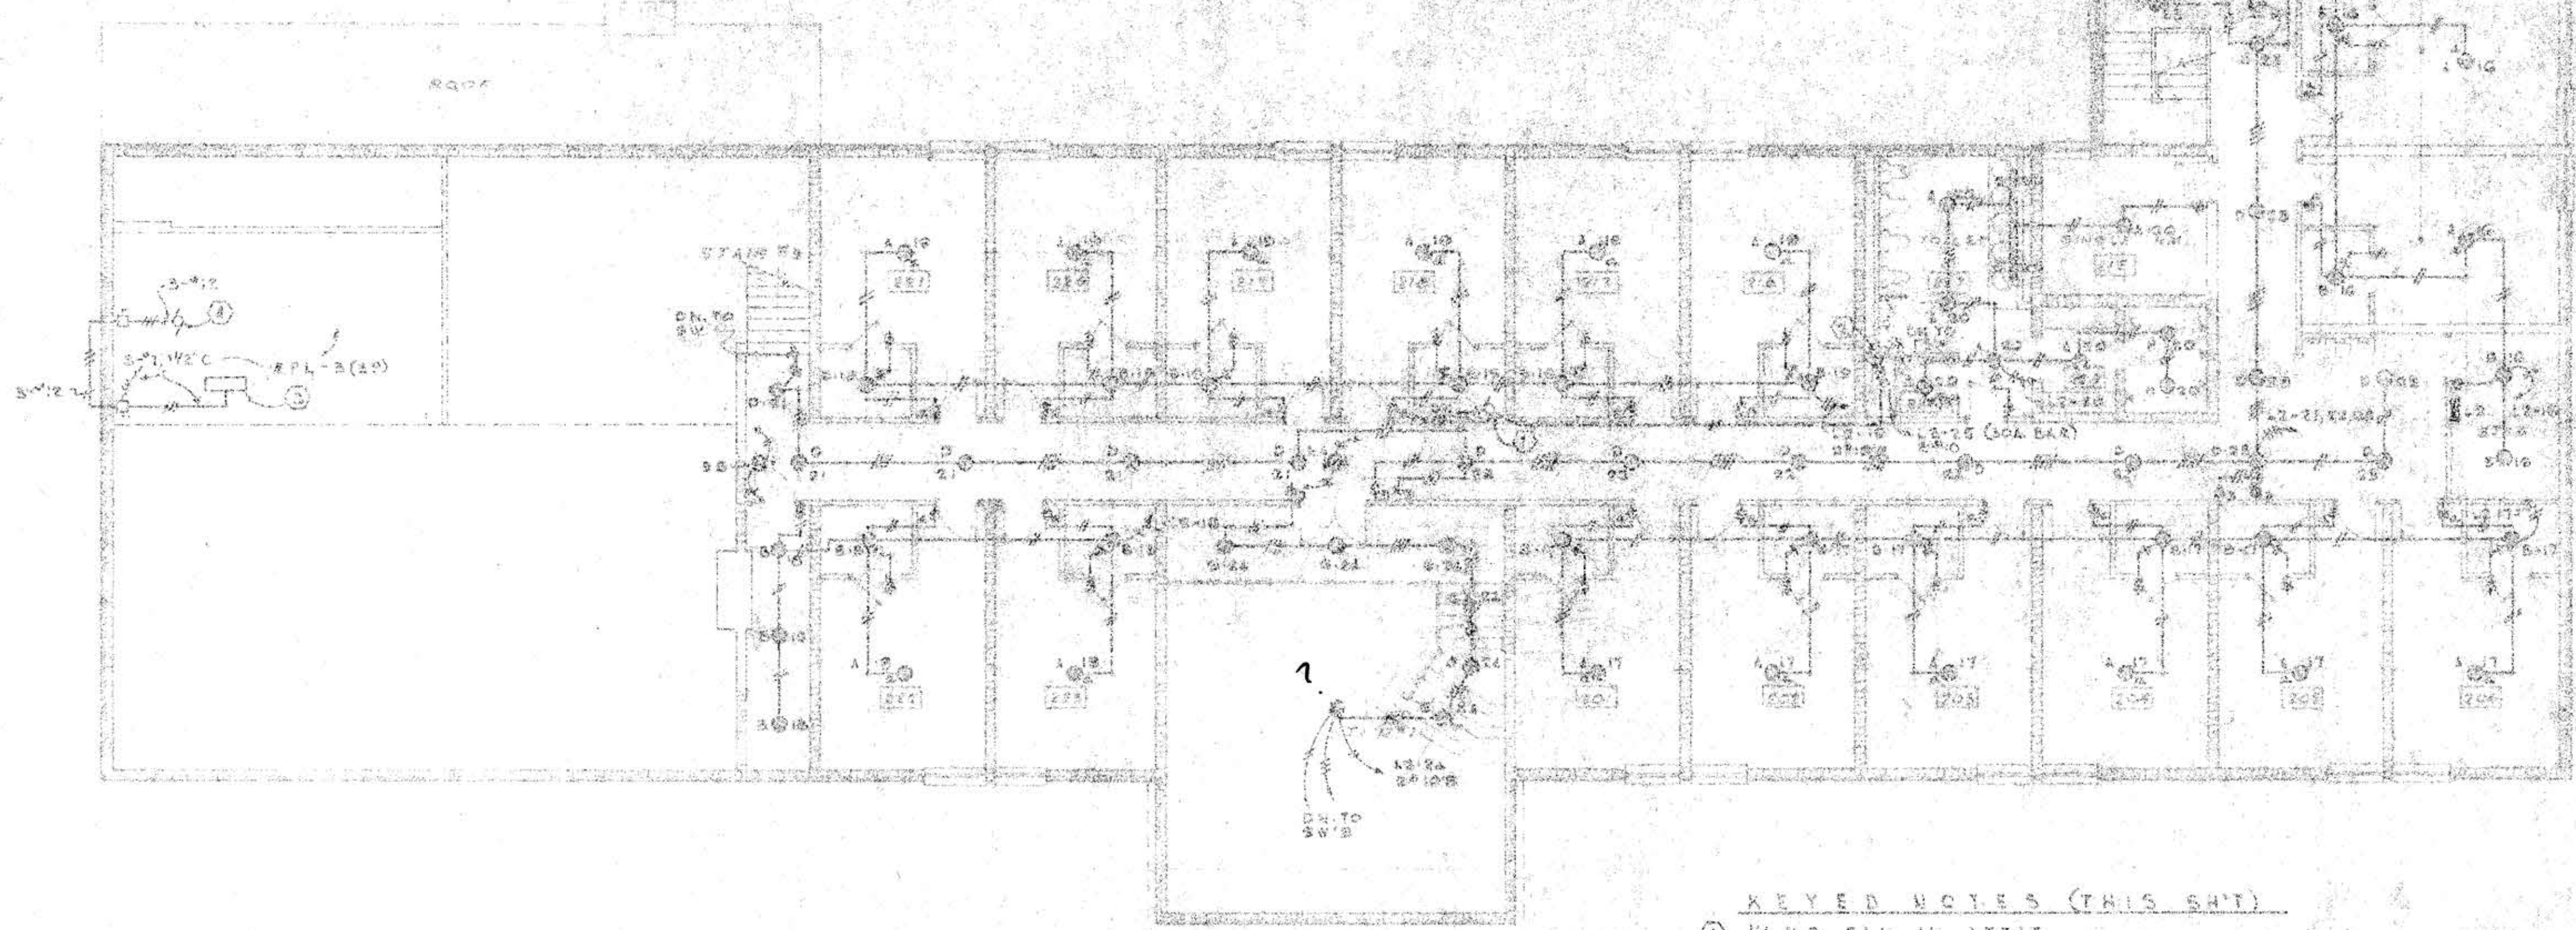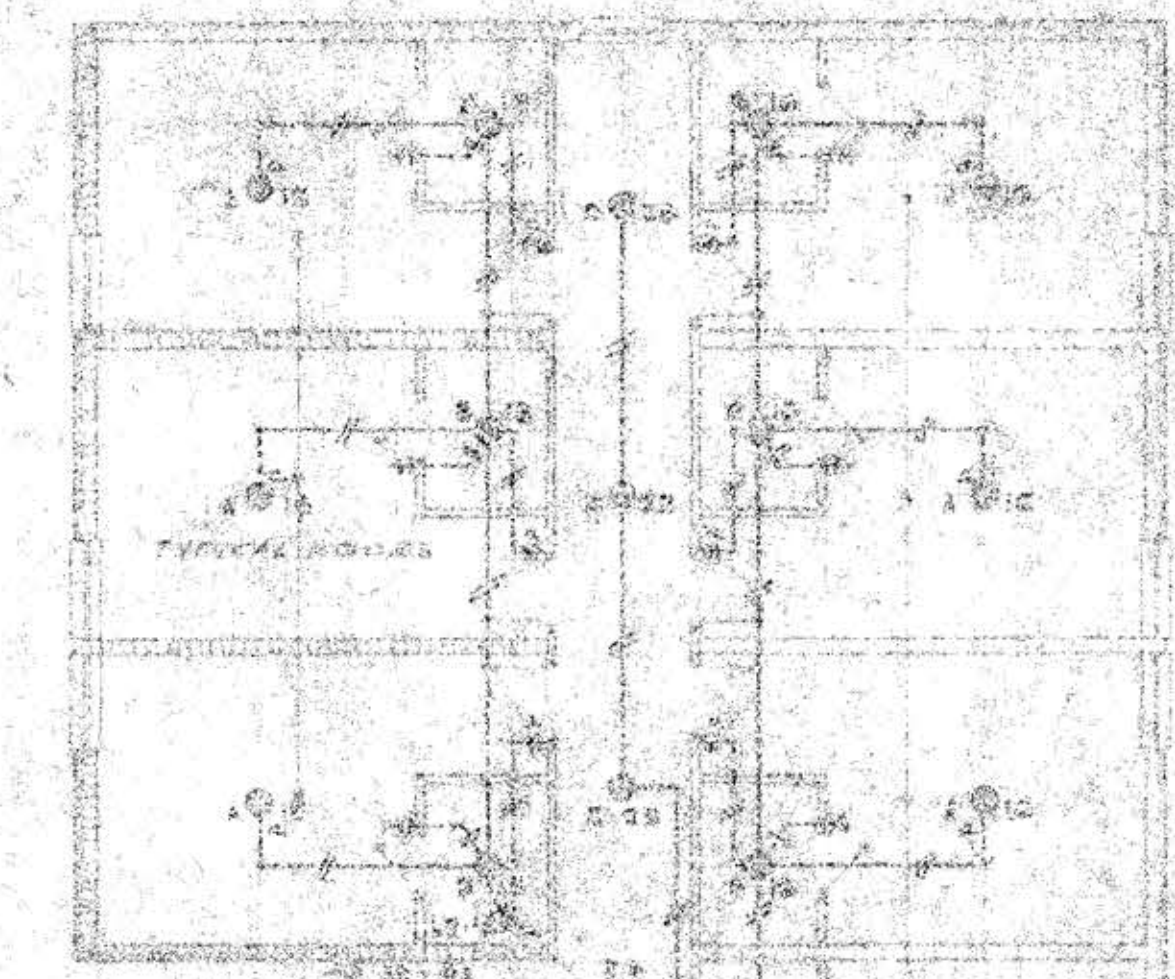

- KEYED NOTES (THIS SHEET)
- ① V&H FAN IN ATTIC
 - ② V&H FAN IN ATTIC
 - ③ ELECTRIC HEAT COIL IN AIR HANDLER 208V/3Ø
 - ④ RMR SLOWER 208V

SECOND FLOOR PLAN
1/8" = 1'-0"

BETA CHI RHO SIGMA HOUSE	
LOVE AND LOT & UNIVERSITY FRATERNITY SUBDIVISION	
UNIVERSITY OF MISSOURI, ROLLE, MISSOURI	
	M. J. COLLINS ARCHITECT ST. LOUIS, MISSOURI
	MATTHEW J. COLLINS ARCHITECT ST. LOUIS, MISSOURI
	SECOND FLOOR PLAN
	15