

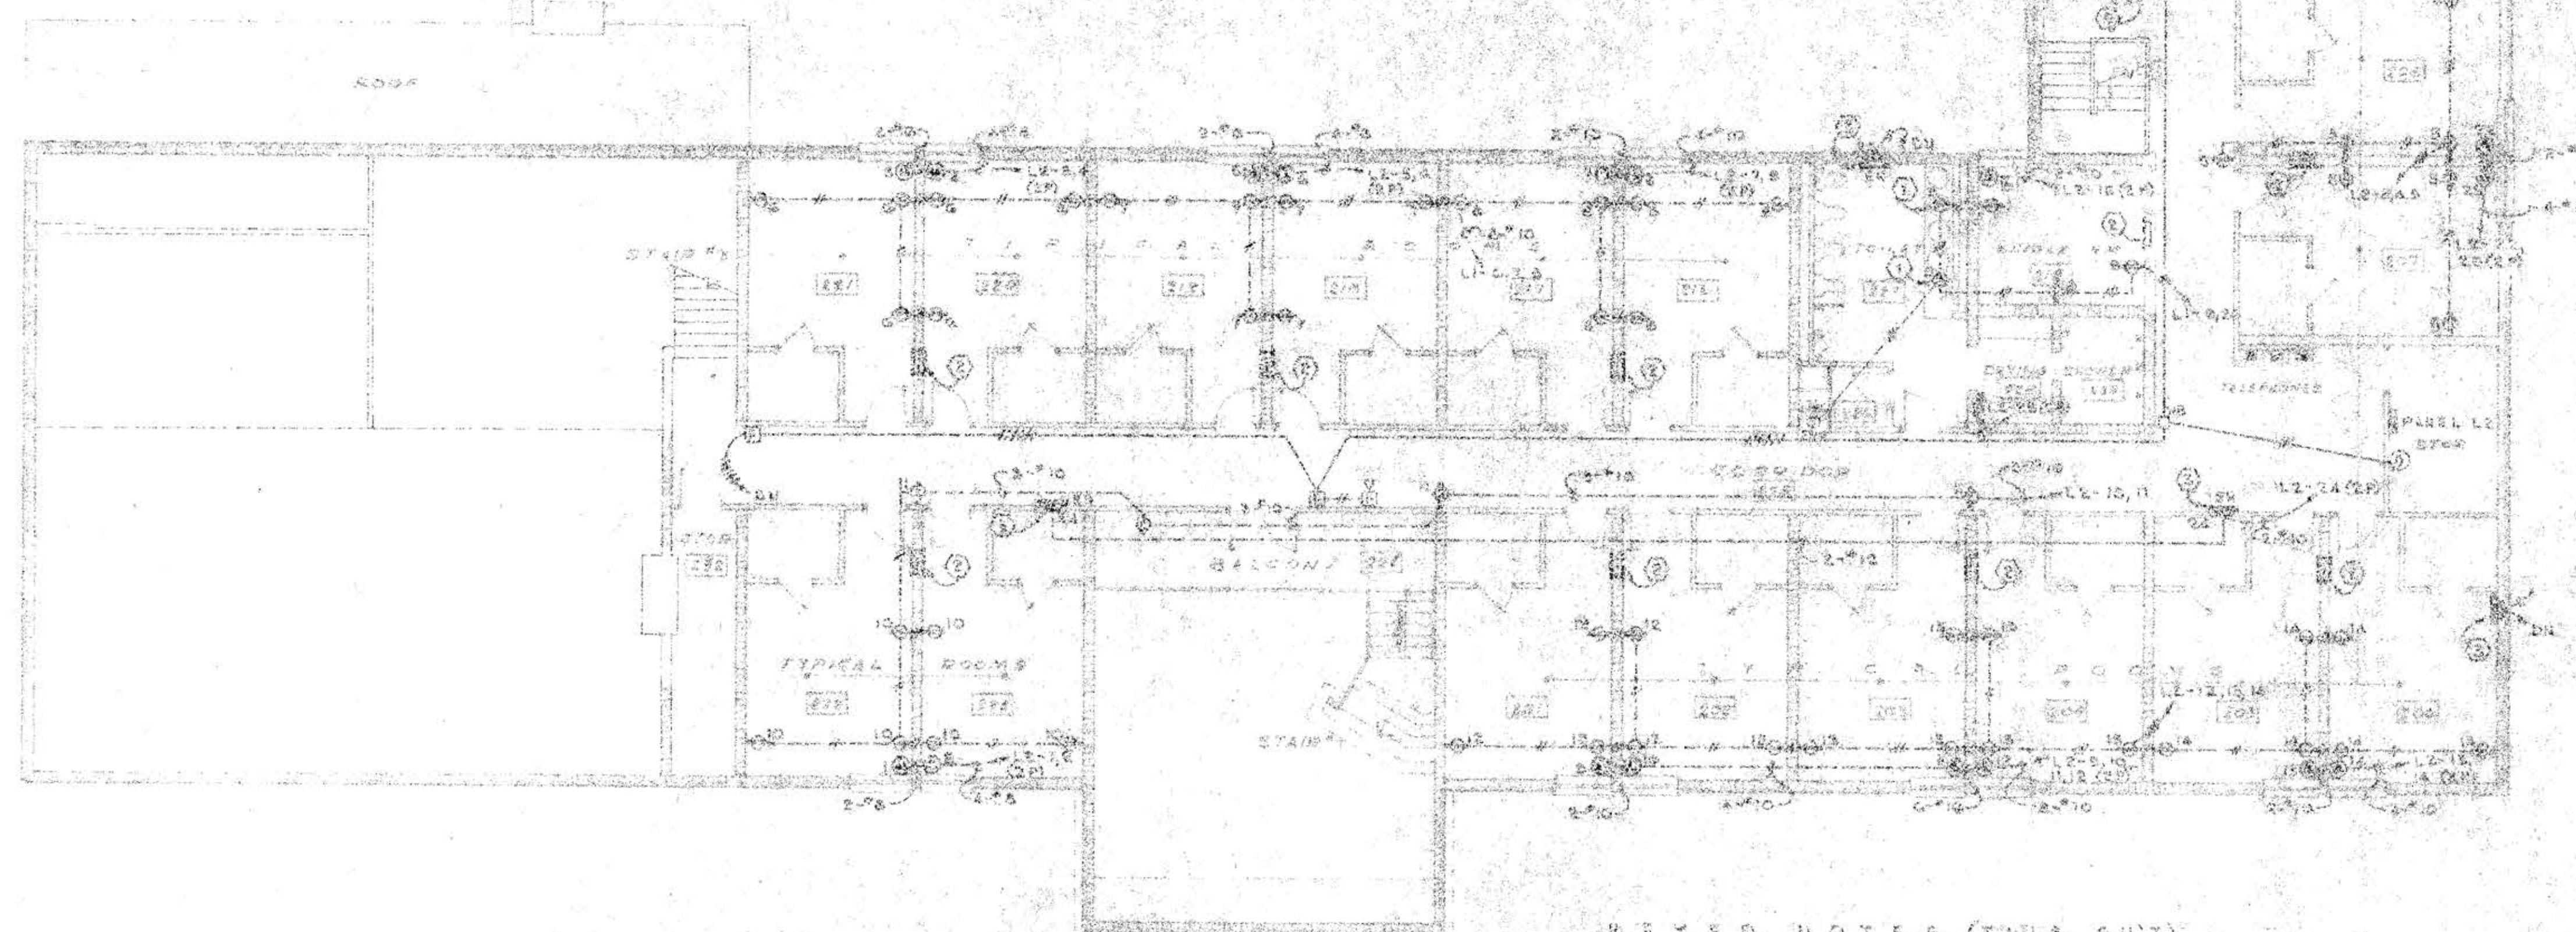
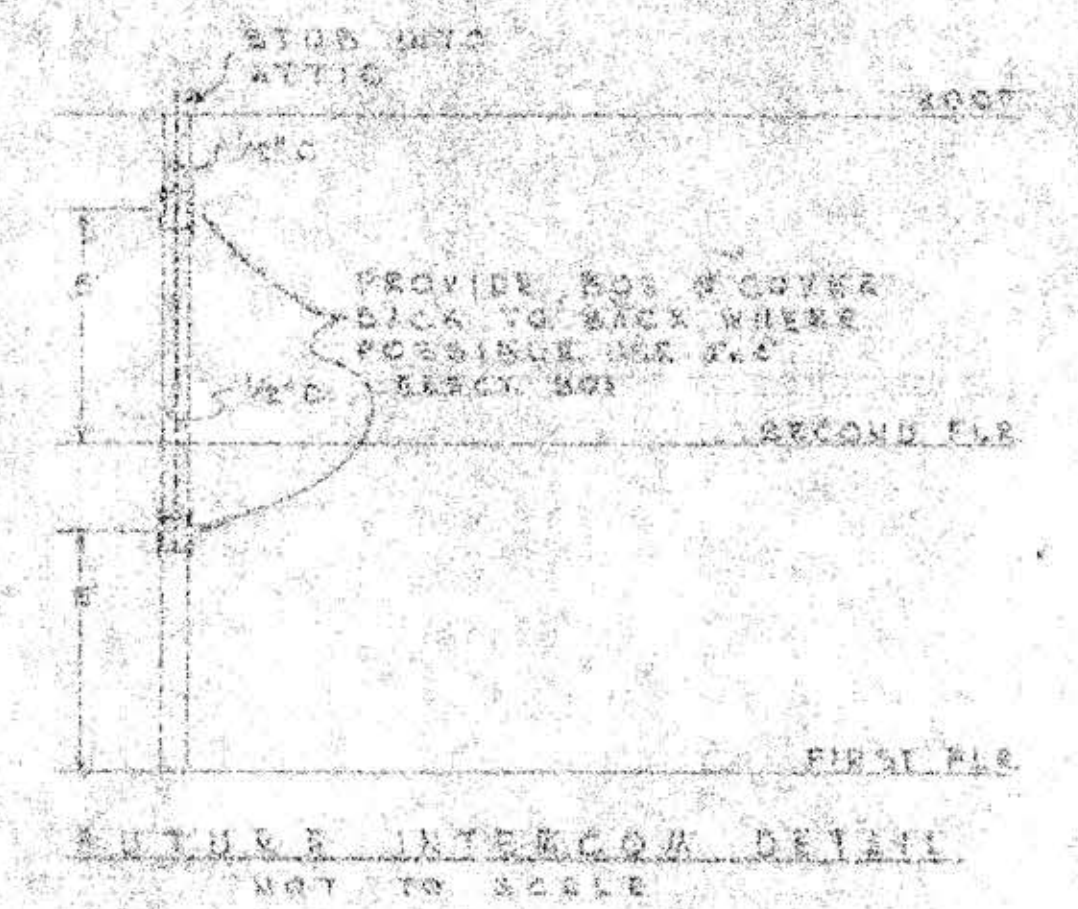


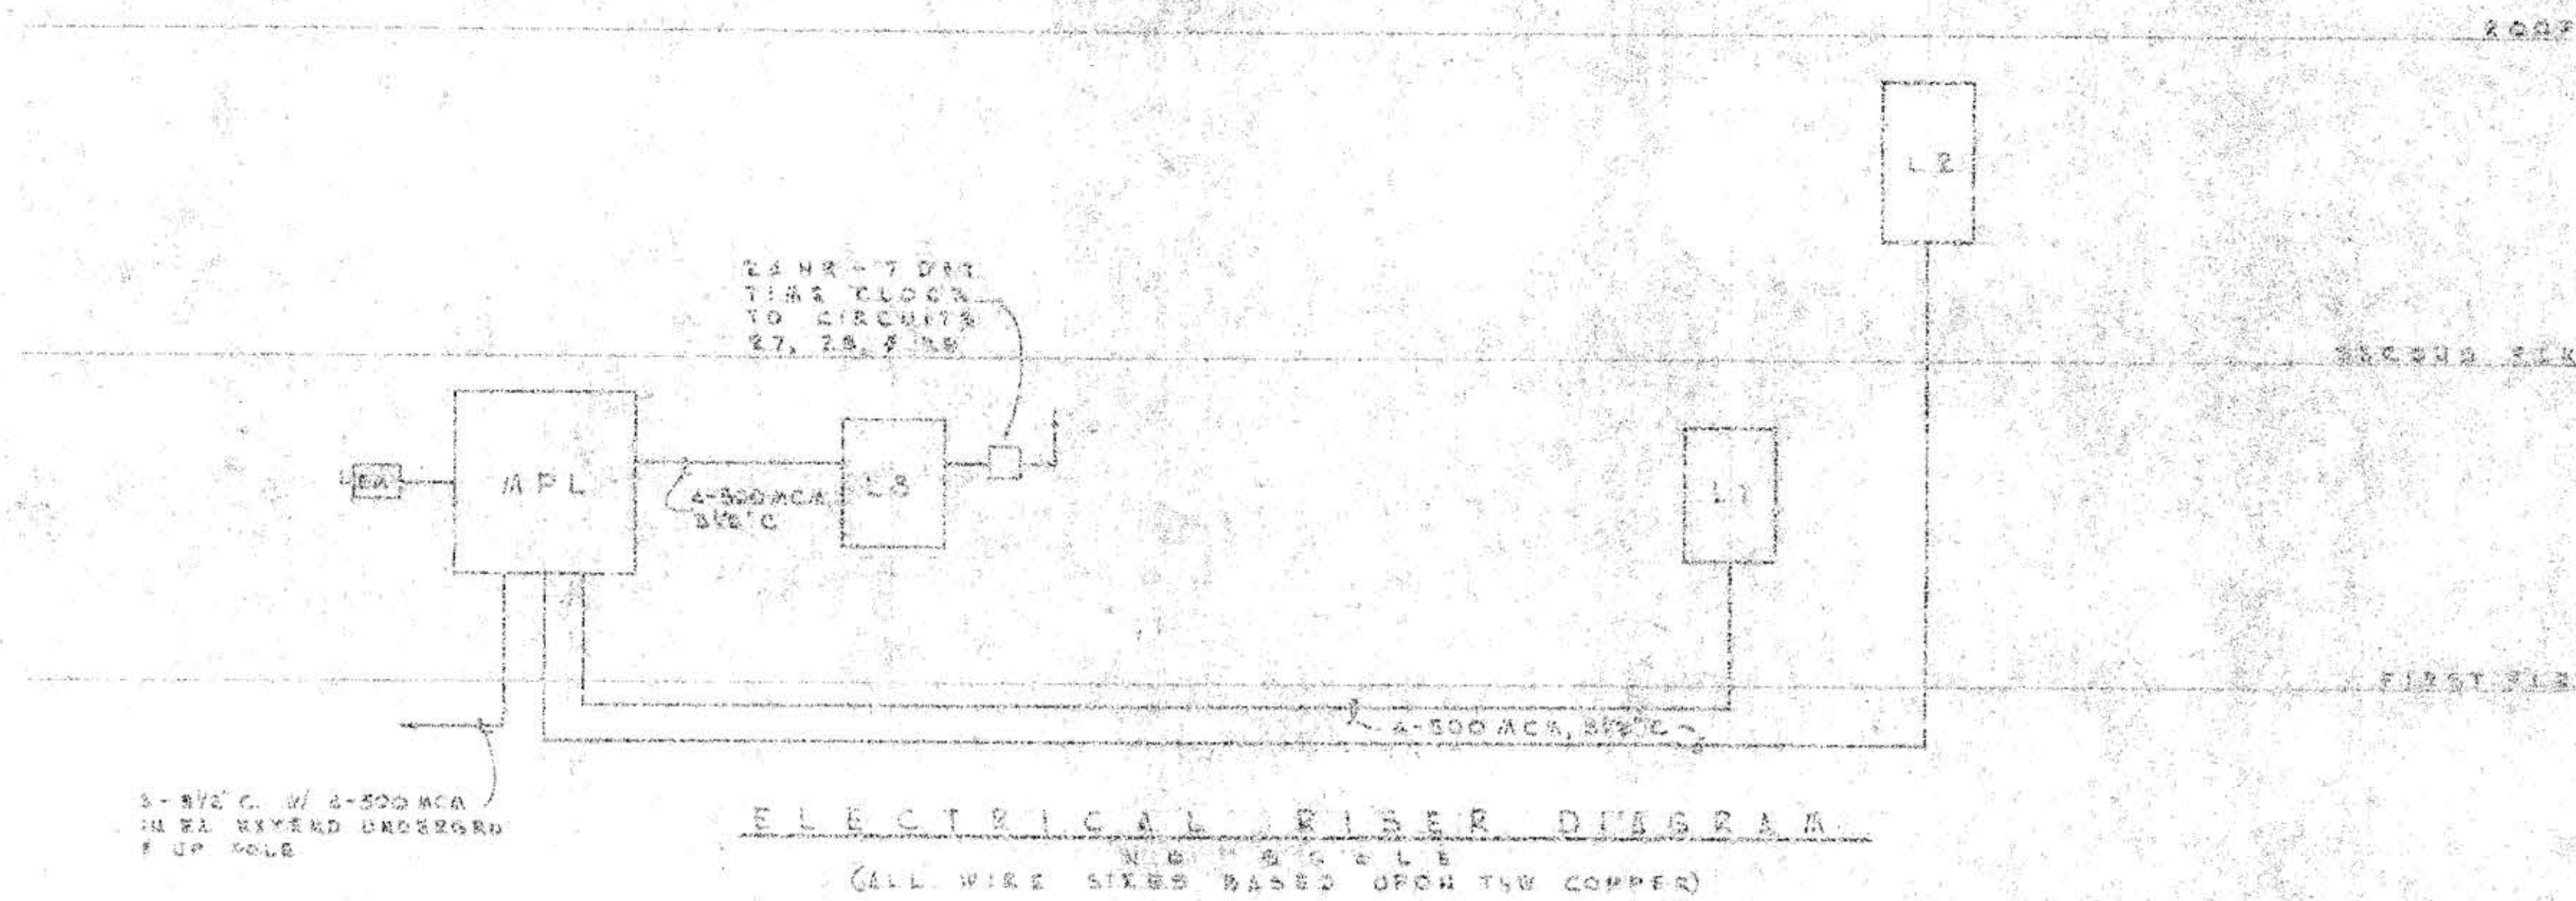


- KEYED NOTES (THIS SH'T)**
- ① MOUNT RECEPTACLES ABOVE COUNTER
 - ② ROUGH-IN FOR FUTURE INTERCOM. SEE DETAIL THIS SH'T
 - ③ ELECTRIC HEATER - 557. CONNECT BY ELECT. CONTR. FURNISHED BY HYG. CONTR.

SECOND FLOOR PLAN
1/8" = 1'-0"

BETA CHI/KAPPA SIGMA HOUSE 1016 AND 1018 UNIVERSITY FRATERNITY SUBDIVISION UNIVERSITY OF MISSOURI COLUMBIA, MISSOURI	
	JAMES H. MCQUINN ELECTRICAL ENGINEER COLUMBIA, MISSOURI

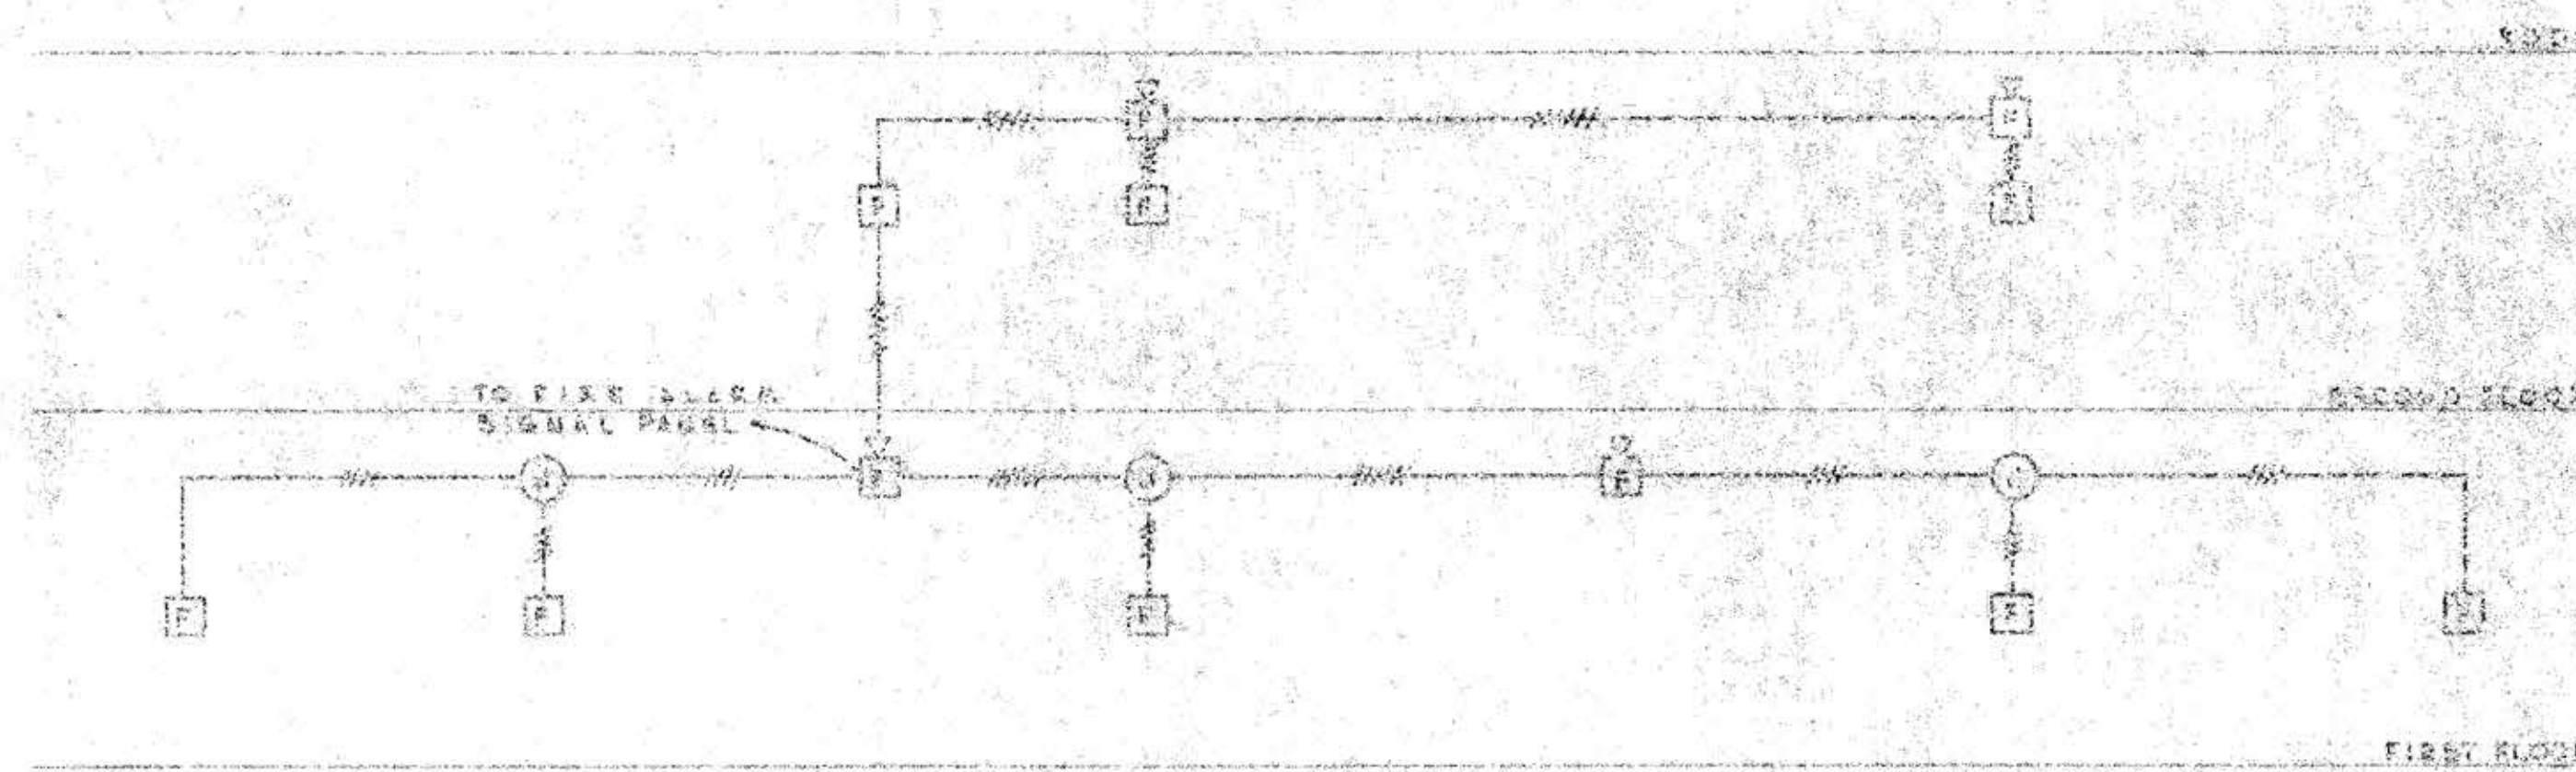

FIRE ALARM SYSTEM DIAGRAM

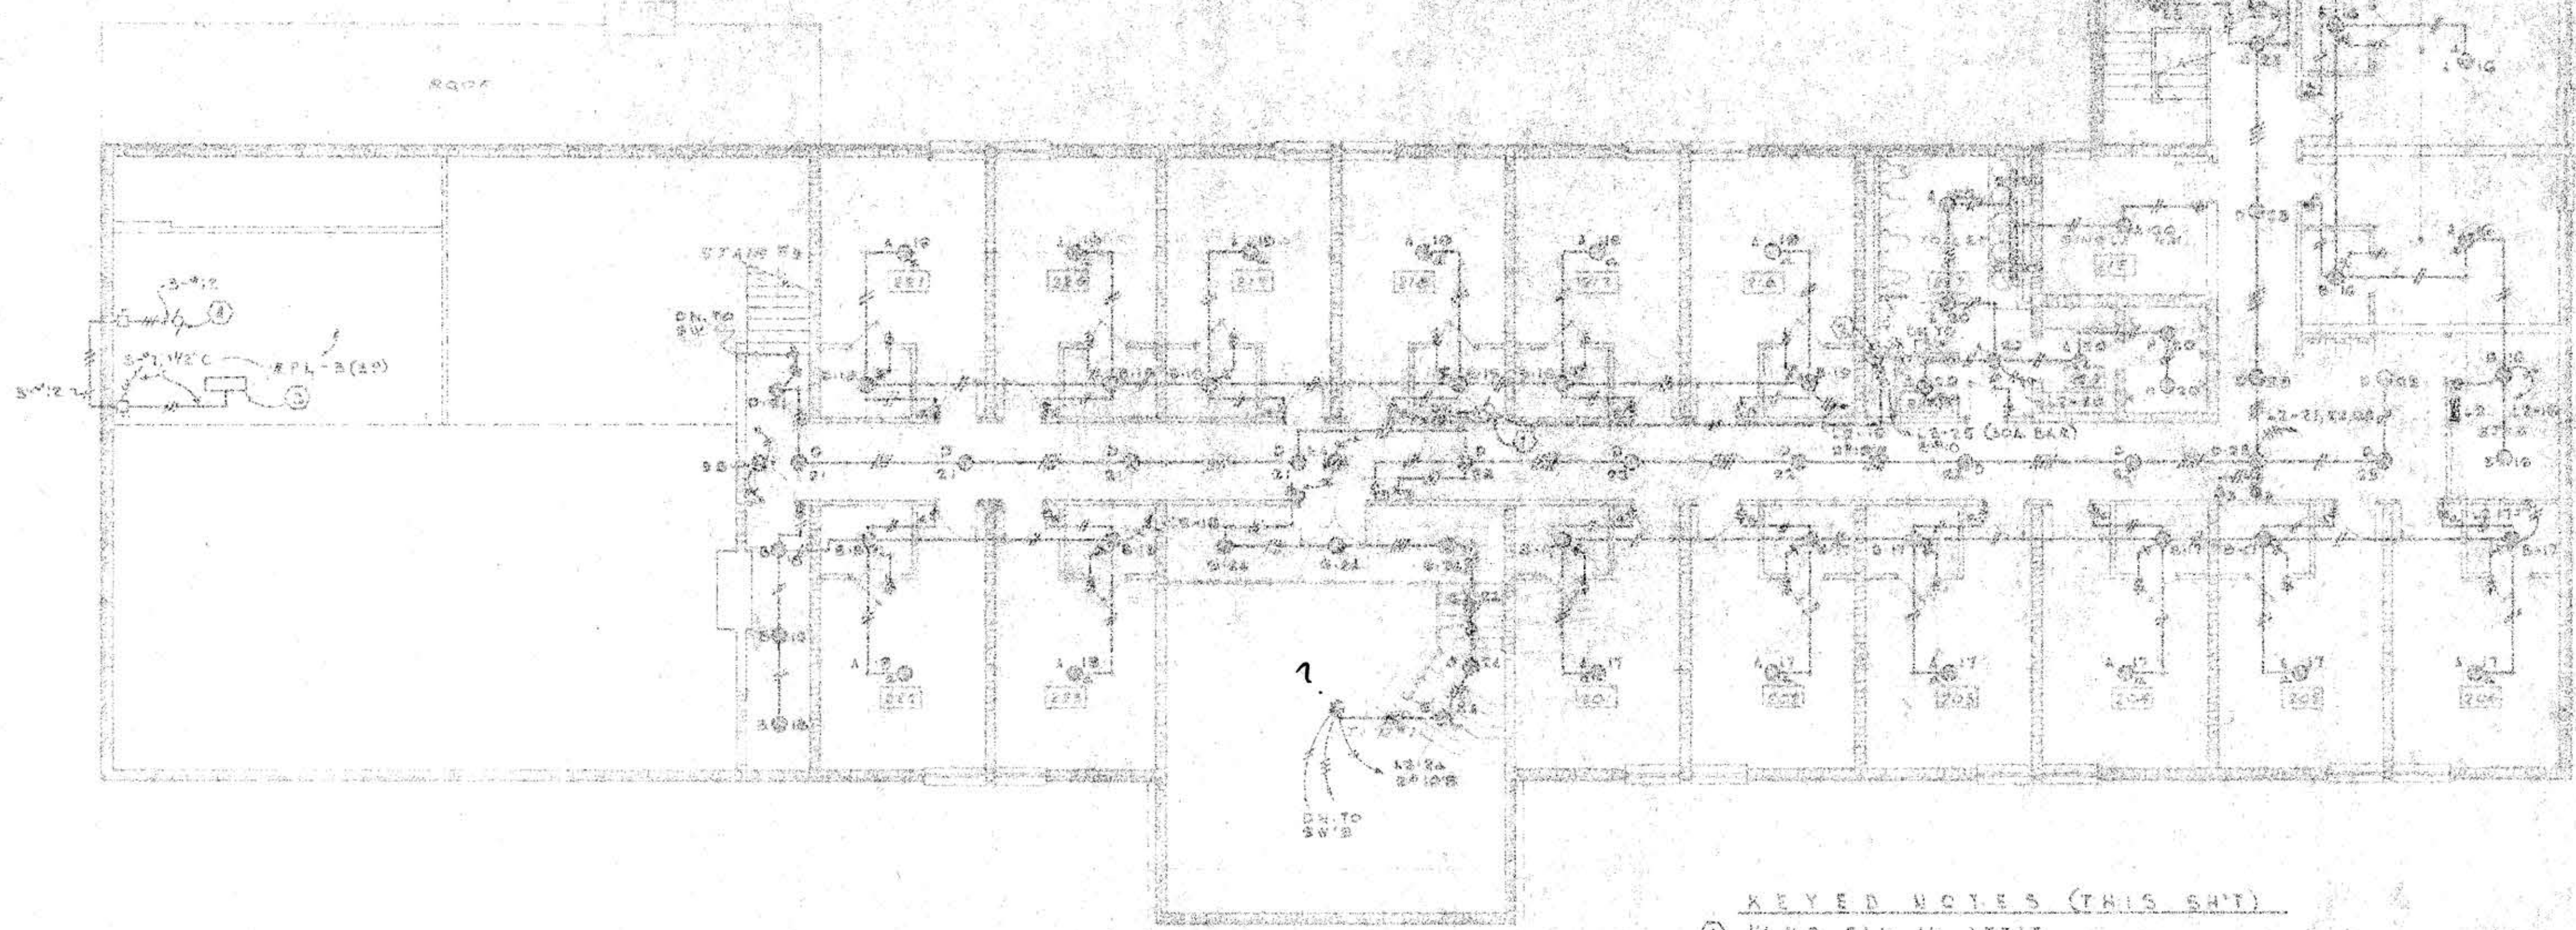

- KEYED NOTES (THIS SHEET)
- ① V&H FAN IN ATTIC
 - ② V&H FAN IN ATTIC
 - ③ ELECTRIC HEAT COIL IN AIR HANDLER 208V/50A
 - ④ RMR SLOWER 208V

SECOND FLOOR PLAN

BETA CHI RHO SIGMA HOUSE	
LOVE AND LOT & UNIVERSITY FRATERNITY SUBDIVISION	
UNIVERSITY OF MISSOURI, ROLLE, MISSOURI	
	DATE: 12/10/80 DRAWN BY: MJC CHECKED BY: MJC PROJECT NO.: 10100
MATTHEW J. COLLINS ARCHITECT ST. LOUIS, MISSOURI	
SECOND FLOOR PLAN	