


GRADING PLAN
SCALE 1/8" = 1'-0"

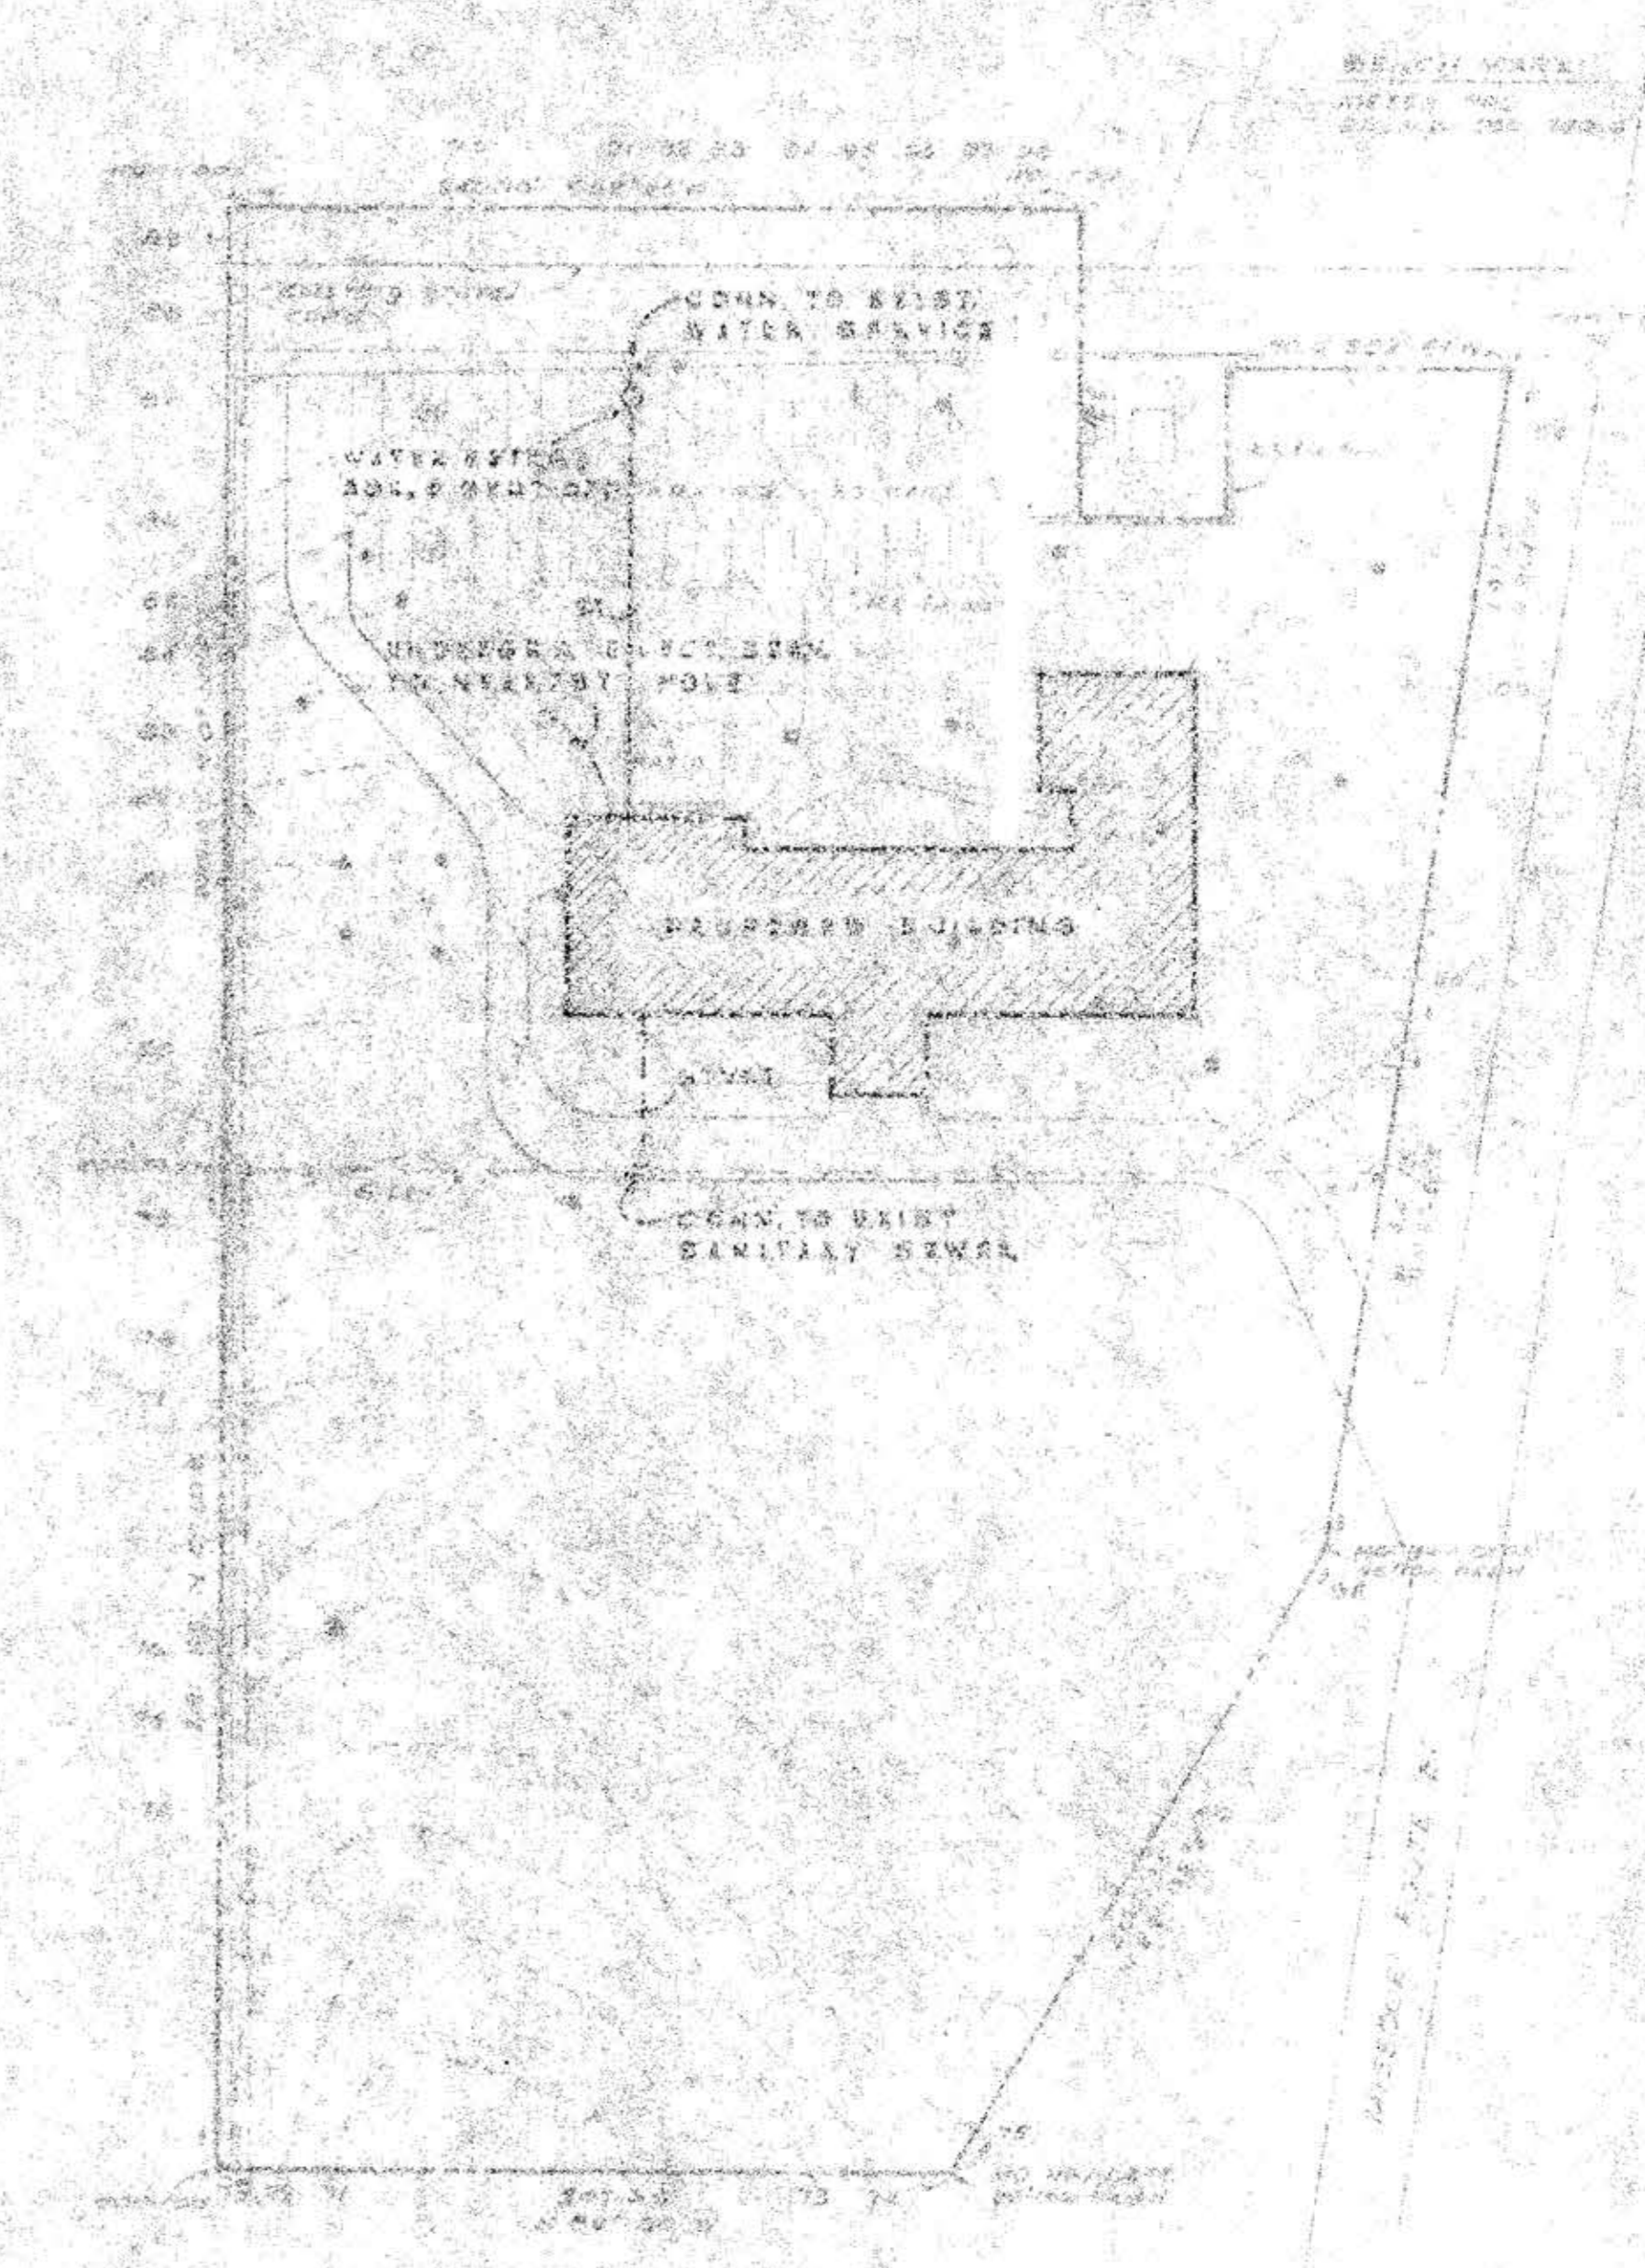


SITE PLAN
SCALE 1/8" = 1'-0"

BETA CHI / ALPHA SIGMA HOUSE
 LOTS 4 AND 1076 UNIVERSITY FRATERNITY SUBDIVISION
 UNIVERSITY OF MISSOURI, COLUMBIA, MISSOURI

DATE: MARCH 1922
 SHEET: 1 OF 2

MAYHEW J. COLLINS
 MECHANICAL & ELECTRICAL ENGINEER
 ST. LOUIS, MISSOURI

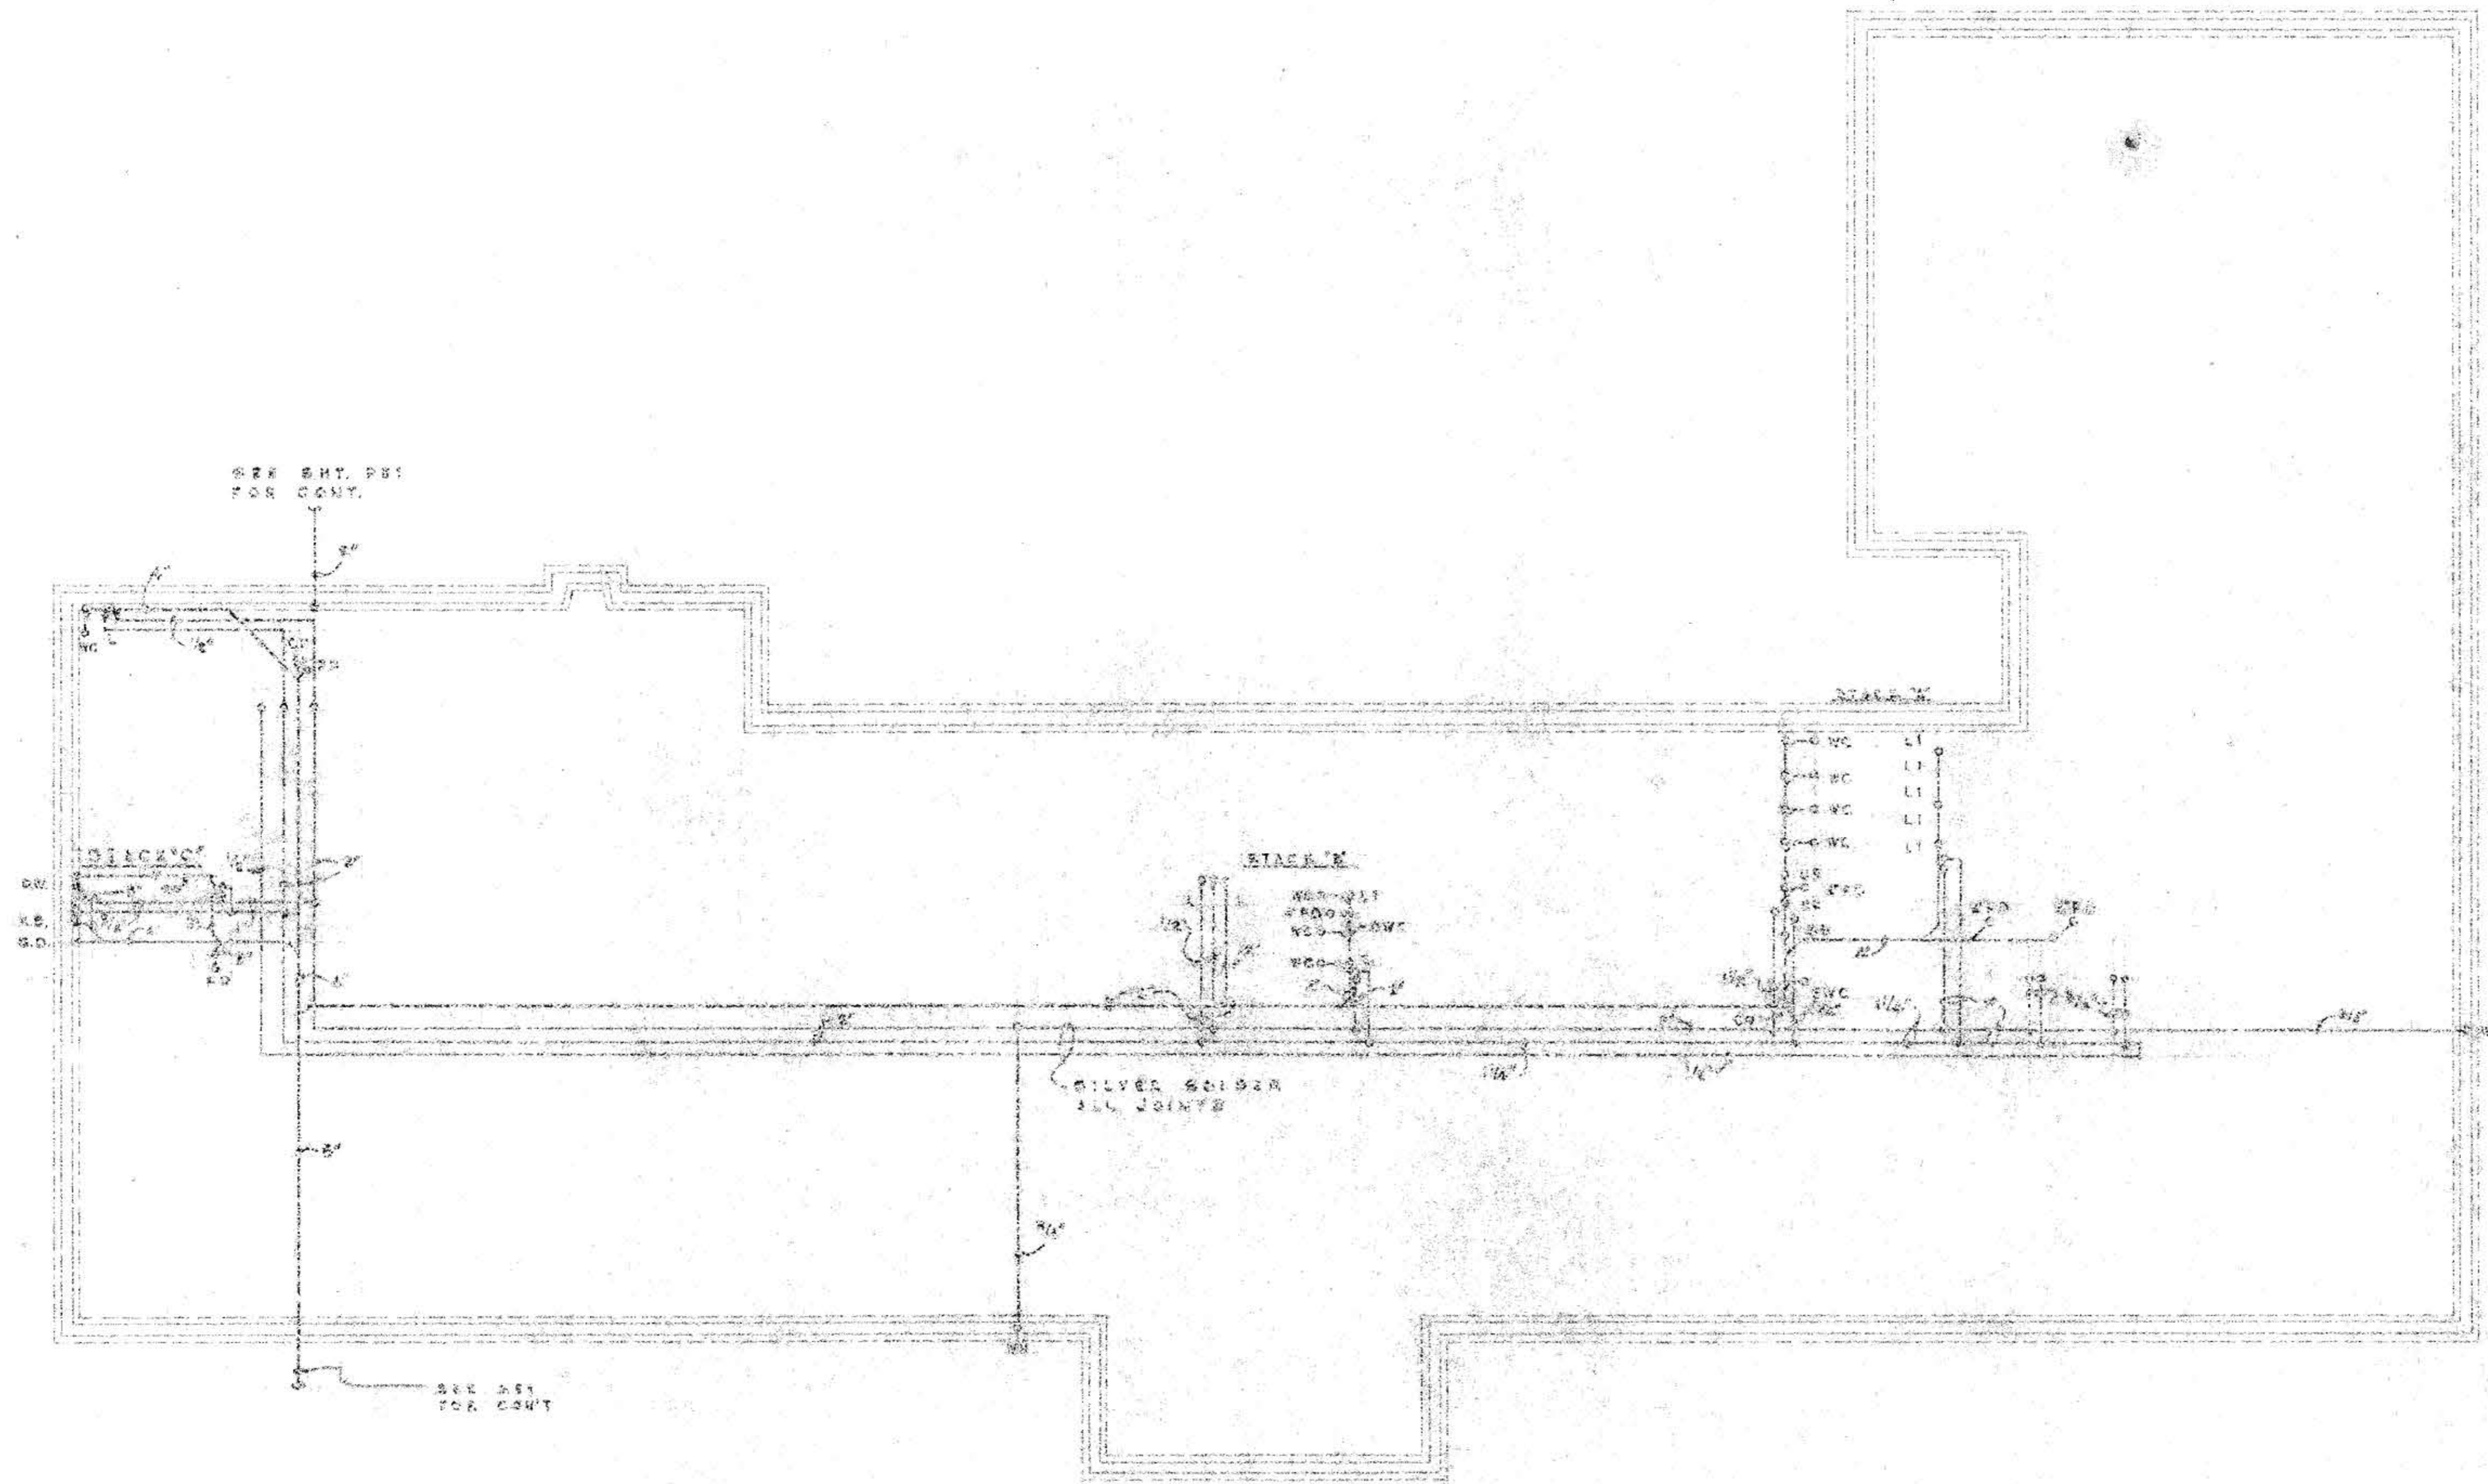

PLBG. SYMBOLS:

- COLD WATER
- HOT WATER
- HOT WATER RETURN
- VENTS & BOIL PIPES
- - - VENT PIPES
- GATE VALVE
- WC. WATER CLOSET
- L. LAVATORY
- UR. URINAL
- SB. SERVICE SINK
- EWC. ELECTRIC WATER COOLER
- KB. KITCHEN SINK
- FD. FLOOR DRAIN
- WH. WALL HYDRANT
- SH. SHOWER
- CO. CLEANOUT
- D.V. DISHWASHER
- G.D. GARBAGE DISPOSAL

FOUNDATION PLAN
SCALE 1/4" = 1'-0"

BETA CHI/KAPPA SIGMA HOUSE LOTS 1 AND 2 UNIVERSITY FRATERNITY SUBDIVISION UNIVERSITY OF MISSOURI - ROLLA, MISSOURI		
	MERVIN A. GIMBERG AND ASSOCIATES INCORPORATED ARCHITECTS ST. LOUIS, MISSOURI	DATE: SHEET NO. SHEETS
	MATTHEW J. COLLINS MECHANICAL & ELECTRICAL ENGR. ST. LOUIS, MISSOURI	
FOUNDATION PLAN		